




JAY R. SMITH MFG. CO.
 MEMBER OF MORRIS GROUP INTERNATIONAL
 POST OFFICE BOX 3237
 MONTGOMERY, ALABAMA 36109-0237 (USA)
 TEL: 334-277-8520 FAX: 334-272-7396 www.jrsmith.com



LOCATION

GREEN ROOF PLANTER DRAIN

STANDPIPE TYPE WITH 5/8" ORIFICE

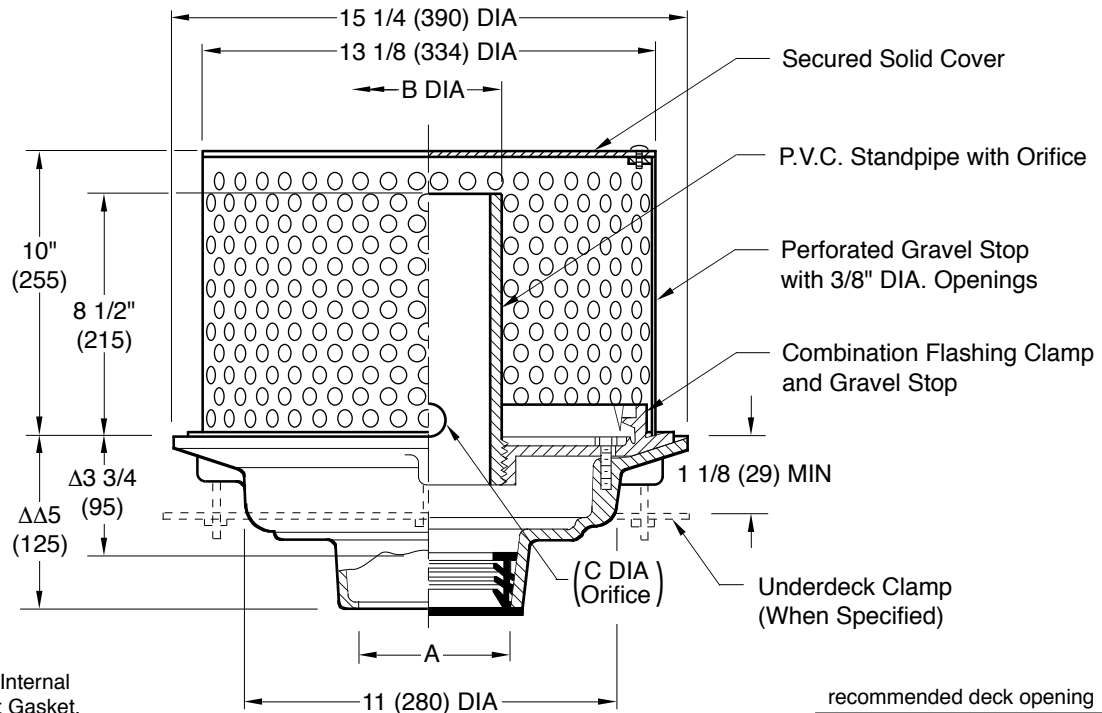

Δ This Dimension to Internal Stop of Speedi-Set Gasket.

ΔΔ Same for Caulk, NO-HUB and Speedi-Set. 3 3/4 (95) for Threaded.

recommended deck opening	
with suffix -R	17 (430) DIA
less Suffix -R	14 (355) DIA

A(Pipe Size)	02(50)	03(75)	04(100)	05(125)	06(150)	08(200)
B (DIA)	4(100)	4(100)	4(100)	6(150)	6(150)	8(200)
C (DIA)	5/8(16)	5/8(16)	5/8(16)	1(25)	1(25)	1(25)

- Fig. 1901C CAULK OUTLET
- Fig. 1901Y NO-HUB OUTLET

REGULARLY FURNISHED:
 Duco Cast Iron Body, Flashing Clamp and Stainless Steel Perforated Gravel Stop with P.V.C. Standpipe with Orifice, and Solid Secured Cover.

- VARIATIONS:**
- Adjustable Extension(Specify Fig. 1045)
 - Expansion Joint (Specify Fig. 1710)
 - Extension (Specify Height) -E
 - "L" Shaped Underdeck Clamp -CL
 - L Speedi-Set Service Weight
 - LXH Speedi-Set Extra Heavy
 - Secondary Flashing Clamp -C2
 - Sump Receiver -R
 - Underdeck Clamp -C
 - Vandal Proof Gravel Stop -U
 - T Threaded Outlet

- OPTIONAL MATERIALS:**
- Bronze Standpipe -BZS
 - Cast Iron Standpipe -CIS
 - Galvanized Cast Iron Body and Collar -G

NOTE: Dimensions shown in parentheses are in millimeters.

DRAWING NUMBER: S1901
 SIZE: A
 SCALE: NONE
 DATE: 11/01/05
 APPROVED BY: AM
 CHECKED BY: AM
 DRAWN BY: JJ
 FIGURE NUMBER: 1901

WE CAN ASSUME NO RESPONSIBILITY FOR USE OF SUPERSEDED OR VOID DATA
 DIMENSIONS ARE SUBJECT TO MANUFACTURERS TOLERANCE AND CHANGE WITHOUT NOTICE

REV.	DATE	DESCRIPTION	BY	CKD. BY	WEIGHT POUNDS	VOLUME CUBIC FEET	FIGURE NUMBER
	5-4-17	Rev. Regularly Furnished, Callout	TBW	CL			1901
	5-22-15	Revised Text	TBW	CL			
	10/27/10	Revised Drawing	RN	AM			
	03/25/10	Removed SQ note, Added Text	JJ	TK			


FIGURE NUMBER	1901BS	DRAWN BY: JJ	CHECKED BY: JM	APPROVED BY: JM	DATE: 08/09/07	SCALE: NONE	SIZE A	DRAWING NUMBER S1901BS	B
---------------	---------------	-----------------	-------------------	--------------------	-------------------	----------------	-----------	---------------------------	---

DIMENSIONS ARE SUBJECT TO MANUFACTURERS TOLERANCE AND CHANGE WITHOUT NOTICE

WE CAN ASSUME NO RESPONSIBILITY FOR USE OF SUPERSEDED OR VOID DATA

SPECIAL PURPOSE GREEN ROOF DRAINS

INSTALLATION ILLUSTRATION

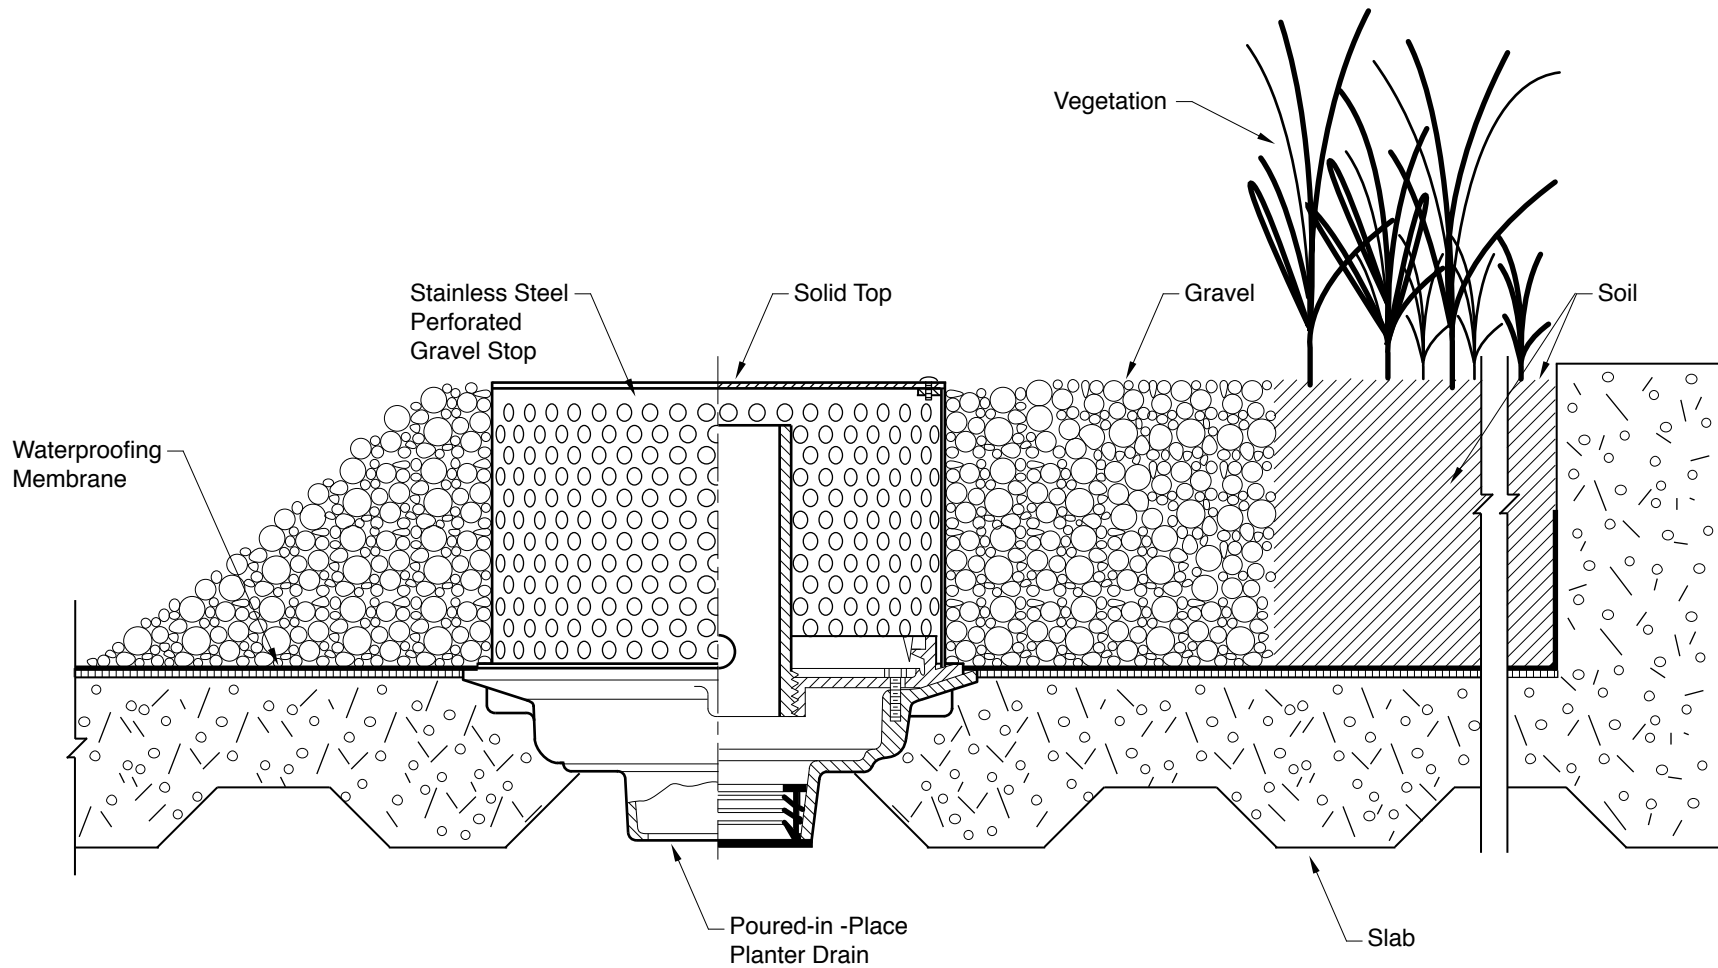

SPECIAL PURPOSE ROOFTOP PLANTER DRAIN



JAY R. SMITH MFG. CO.®
 MEMBER OF MORRIS GROUP INTERNATIONAL
 POST OFFICE BOX 3237
 MONTGOMERY, ALABAMA 36109-0237 (USA)
 TEL: 334-277-8520 FAX: 334-272-7396 www.jrsmith.com



MEMBER OF:

B A	5-22-15 07/10/08	Revised Text Added Membrane & Vegetation	TBW JJ	CL JM
REV.	DATE	DESCRIPTION	BY	CKD. BY